


**Elec Room
ST202**

**Elec Room
ST200E**


South Terminal

**Areas anticipated to be impacted by Substation
ST-AB outage- Upper Level**

**Approx
location of
SUS ST-AB
(below)**

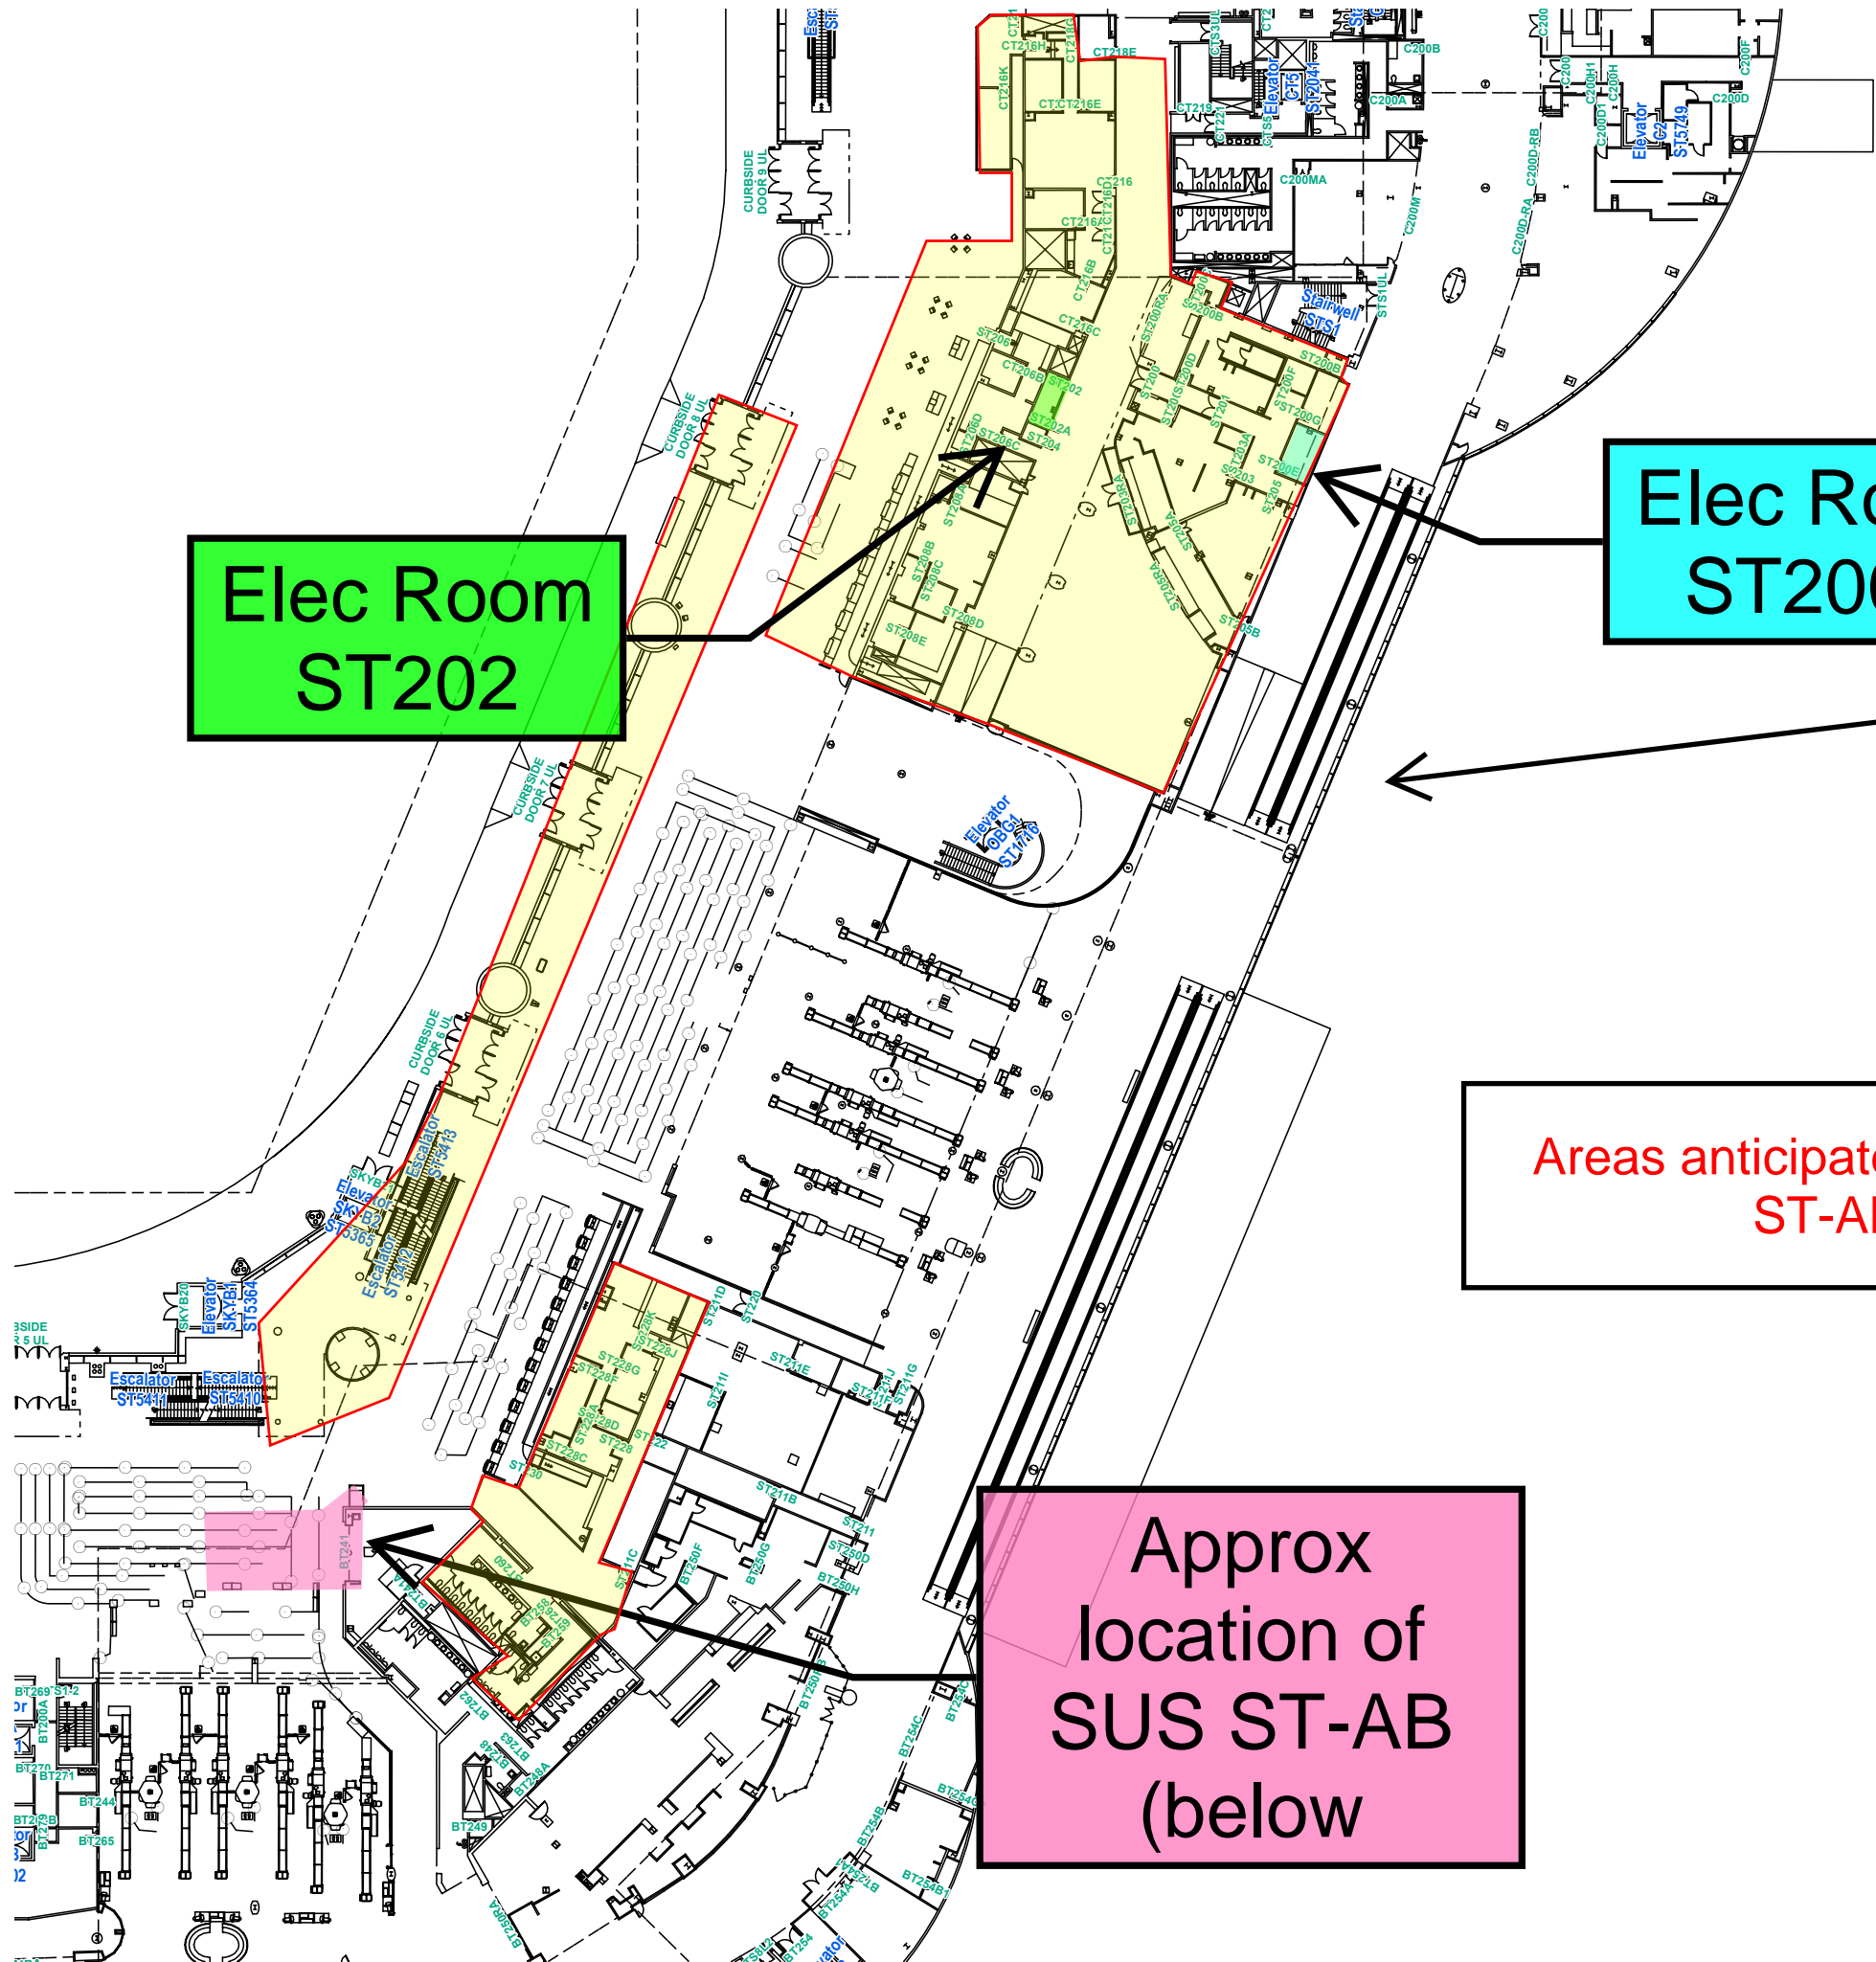

Substation ST-AB (BT146)

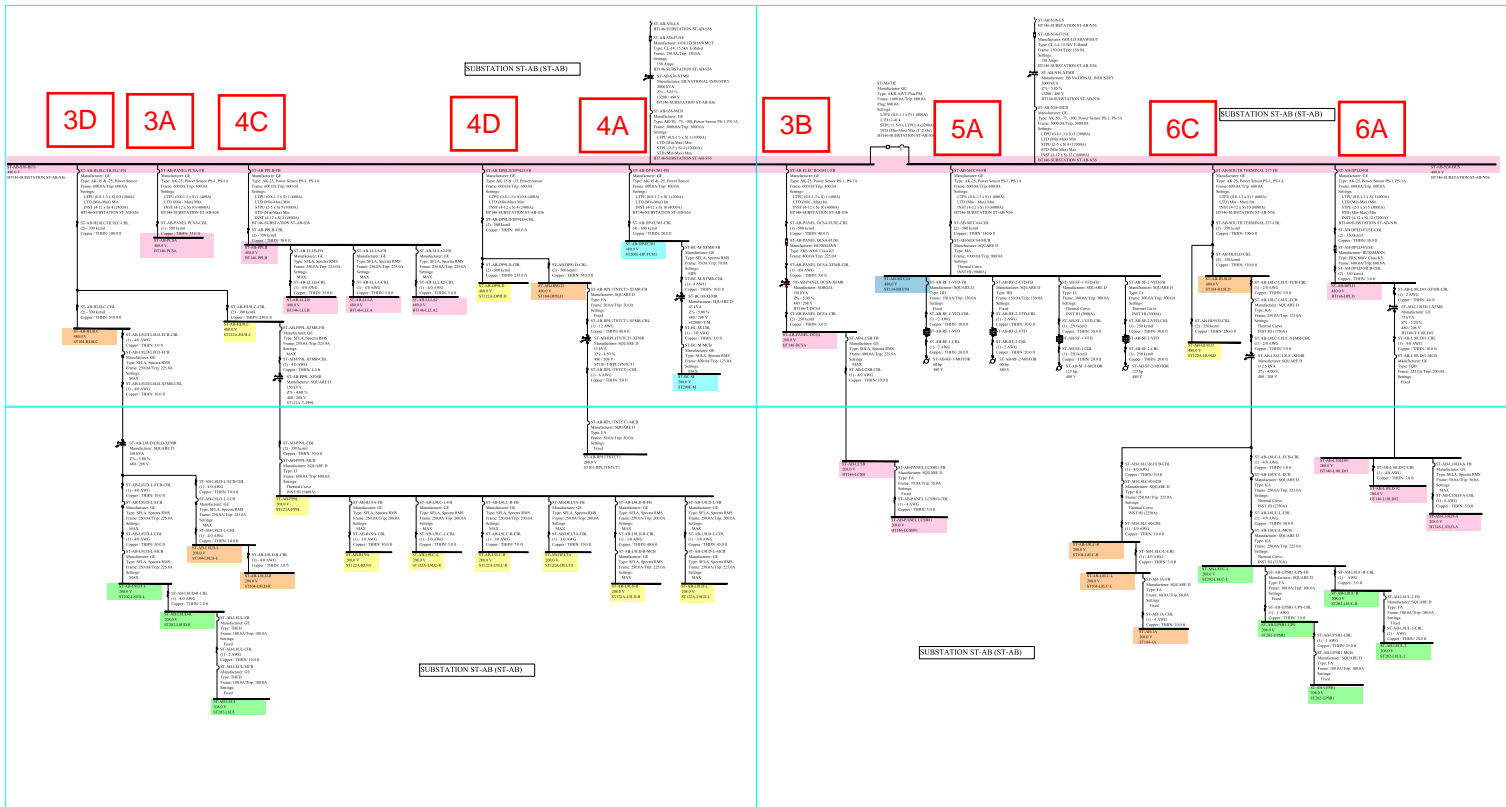

- Substation ST-AB (Lower)
- Electrical Room ST122A (Lower)
- Electrical Room ST104 (Lower)
- MER #4 ST134 (Lower)
- Electrical Room ST202 (Upper)
- Electrical Room ST200E (Upper)



MARYLAND DEPARTMENT OF TRANSPORTATION
MARYLAND AVIATION ADMINISTRATION
OFFICE OF ENGINEERING AND CONSTRUCTION

PROJECT TITLE: TASK 4428 - ARC FLASH HAZARDS ENERGY CALCULATIONS & LABELING @ BWI AND MARTIN STATE AIRPORT

SHEET TITLE: ONE LINE DIAGRAM - INPUT DATA - SUBSTATION ST-AB - KEY PLAN

URS CONSULTING ENGINEERING AND PLANNING	SCALE: AS NOTED	CONTRACT NO.: MAA-AE-14-012	SHEET NO.: E-305a
	DATE: 3/15/2018	SHEET NO.: 132 OF 731	